


PLUMBING RISER

2
A-1
NOT TO SCALE

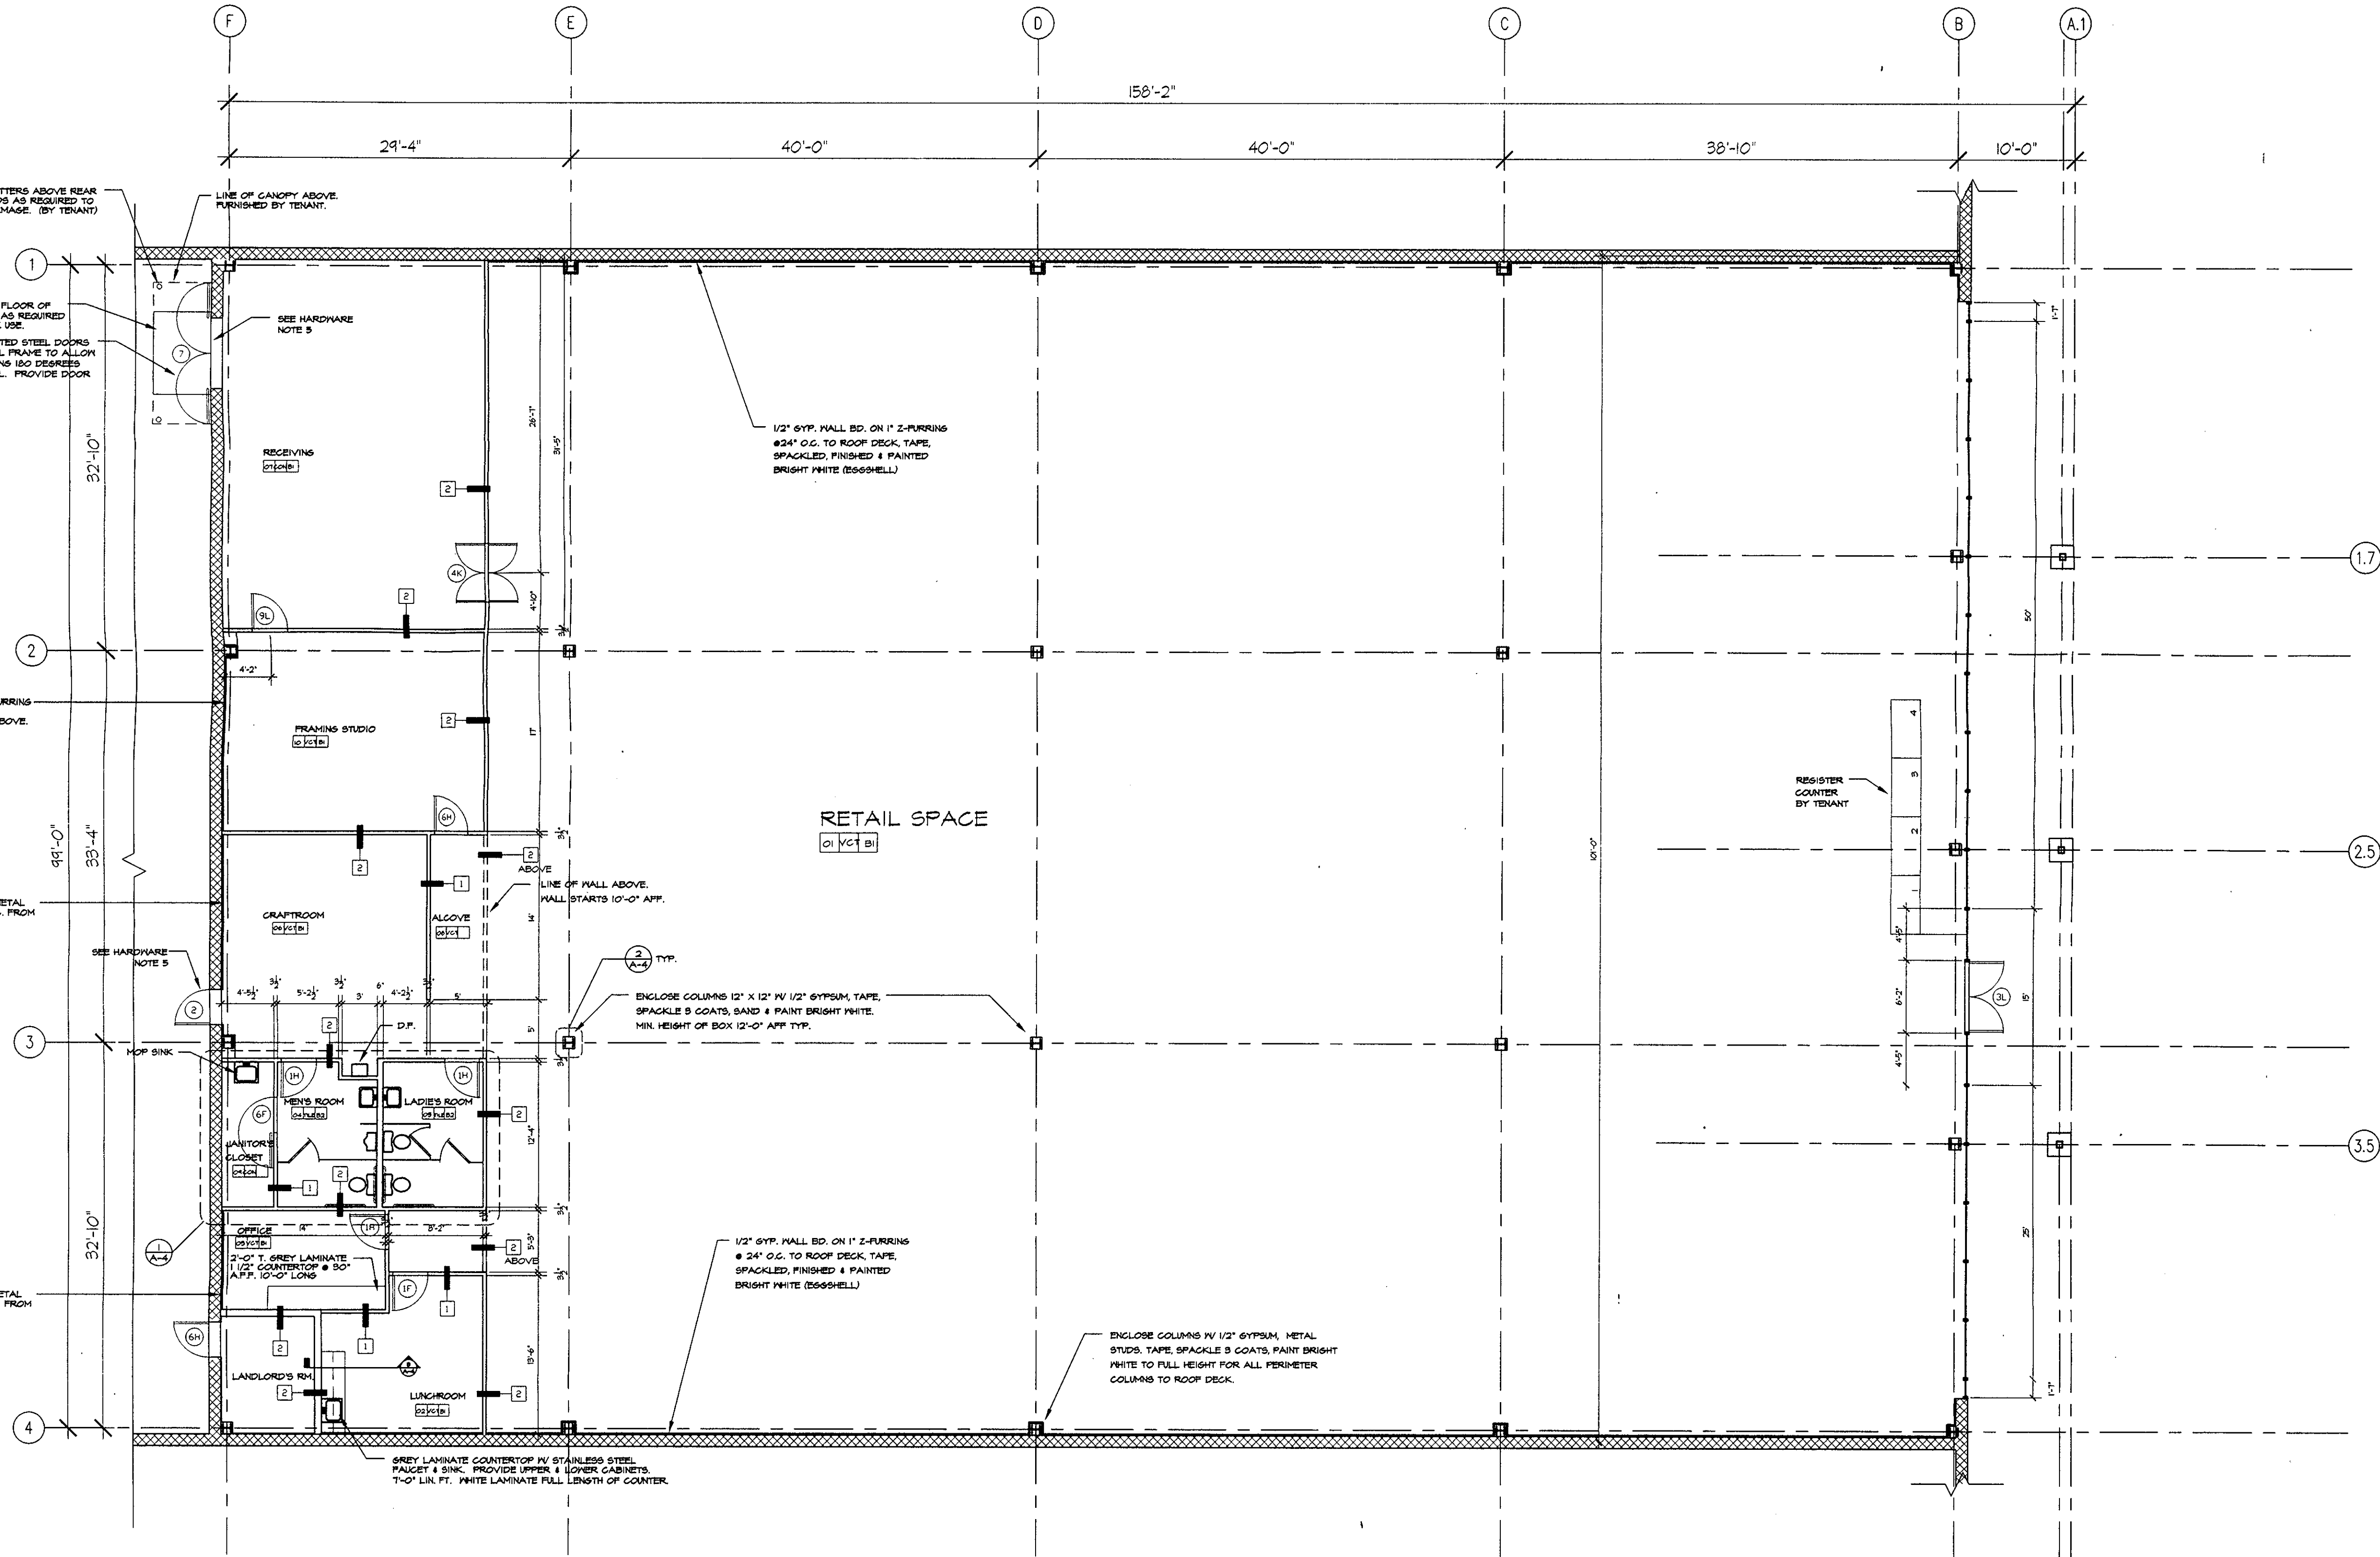

CONSTRUCTION PLAN

1
A-1
1/8" = 1'-0"

8/13/18 REVISED PER OWNER'S COMMENTS
1/24/18 REVISED
7/22/18 REVISED
1/8/18 REVISED

WSJS ARCHITECTS
755 NEW YORK AVE., HUNTINGTON, N.Y.
(516) 351-1999

ARCHITECTURE INTERIORS PLANNING

THESE PLANS ARE AN INSTRUMENT OF SERVICE AND ARE THE PROPERTY OF THE ARCHITECT. INFRINGEMENTS WILL BE PROSECUTED.
THE CONTRACTOR SHALL VERIFY ALL FIELD CONDITIONS AND BE RESPONSIBLE FOR FIELD FIT AND QUANTITY OF WORK. NO ALLOWANCES SHALL BE MADE IN BEHALF OF THE CONTRACTOR FOR ANY ERROR OR NEGLIGENCE ON HIS PART.

WILLIAM SCHERER AI 07111
JOHN SEIFERT AI 15216

CERT. NO.

PROJECT NAME
PROPOSED INTERIOR ALTERATIONS FOR THE
RAG SHOP
MARKETPLACE AT MANVILLE SOMERSET, N.J.

DRAWING TITLE
CONSTRUCTION PLAN

DRAWN BY CK

DRAWING NUMBER

CHKD BY JS

DATE 6/17/18

PROJ #

SCALE 1/8"=1'-0"

A-1