

A DRAFT STOP DETAIL
SCALE: 1/8" = 1'-0"

- CEILING LEGEND**
- CLG-1 NEW CEILING ASSEMBLY
 - CLG-2 NEW ACoustICAL CEILING TILE BY ANSONSING, FIRE RATED SECTION BY 2x4x8 TYP. INCLUDE 5/8" TIE ROD HANGERS AND INSTALLED IN CEILING ASSEMBLY
 - CLG-3 1/2" X 1/2" X 1/2" TYP. X-GYPSUM BOARD OVER 1/2" X 1/2" X 1/2" TYP. GYPSUM BOARD AND SECTION OF SCREED
 - CLG-4 NEW CEILING ASSEMBLY
 - CLG-5 NEW FIBER GLASS PANEL, 48" AMERICAN ACUSTIC HOUS-505 HANGERS BY UDL, VENDOR AND INSTALLED BY 166C.
 - CLG-6 NEW CEILING ASSEMBLY FOR AVOID SYSTEM, FINISHED BY 166C. REFER TO SHEET 166C FOR INSULATION DETAILS.
 - CLG-7 NEW CEILING ASSEMBLY FOR AVOID SYSTEM, FINISHED BY 166C. REFER TO SHEET 166C FOR INSULATION DETAILS.
 - CLG-8 NEW CEILING ASSEMBLY FOR AVOID SYSTEM, FINISHED BY 166C. REFER TO SHEET 166C FOR INSULATION DETAILS.
 - CLG-9 NEW CEILING ASSEMBLY FOR AVOID SYSTEM, FINISHED BY 166C. REFER TO SHEET 166C FOR INSULATION DETAILS.
 - CLG-10 NEW CEILING ASSEMBLY FOR AVOID SYSTEM, FINISHED BY 166C. REFER TO SHEET 166C FOR INSULATION DETAILS.

- REFLECTED CEILING PLAN NOTES**
1. THESE ACCESS PANELS ARE LOCATED IN SPANNING BEYOND CEILING, VERIFY WITH 166C FOR ACCESS PANEL WITH FINISH.
 2. ALL LIGHTING FIXTURES SHALL BE BY UDL, VENDOR AND INSTALLED BY 166C.
 3. LOCATE DOWN LIGHTS AND OTHER ITEMS IN THE CENTER OF 20" TILES UNLESS OTHERWISE NOTED.
 4. 166C TO LAY TRACK HEADS TO CENTER OF WALL STANDBY'S.
 5. ALL 4x8' LONG LIGHT FIXTURES IN SPACES TO BE GAIN IN 12'-0" AFF. THESE THERE IS NO CEILING INSTALLED. 166C TO PROVIDE ALL NECESSARY WORKMAN FOR HANGING FLUORESCENT STRIPS IN NON-SQUARE SPACES.
 6. 166C TO REFER TO DWG H10 FOR SPEAKER INSTALLATION.
- NOTE: 166C TO REFER TO DWG H10 FOR CIRCUITING.**

- SPRINKLER PLAN NOTES**
1. SPRINKLER PLAN LAYOUT ON THIS SHEET IS DESIGNED TO BE A GENERAL CONCEPT AND IS NOT TO BE CONSIDERED A FINAL DESIGN. THE CONTRACTOR SHALL BE RESPONSIBLE FOR OBTAINING ALL NECESSARY APPROVALS FOR THE ACTUAL SPRINKLER PLAN LAYOUT. APPROVAL OF ALL ACCESS PANELS TO BE PROVIDED BY THE CONTRACTOR.
 2. THESE SPRINKLER HEADS ARE TO BE INSTALLED IN THE CEILING ASSEMBLY.
 3. USE WITH EXISTING PLATES IN GYPSUM BOARD CEILING.
 4. IN ALL STOODS, SPRINKLER HEADS TO BE THIN JET.
 5. INSTALL A SECOND SPRINKLER HEAD ABOVE THE FIRST SPRINKLER HEAD LAYOUT BY GENERAL CONTRACTOR TO BE DETERMINED BY THE CONTRACTOR.
 6. LOCAL GENERAL CONTRACTOR AND SUBCONTRACTOR TO VERIFY ALL LOCAL CODES AND REGULATIONS. IF ALLOWED BY LOCAL CODES TO BE A SPRINKLER SYSTEM AND A SMOKE FREE PLAN WHICH THIS DRAWING IS NOT TO BE CONSIDERED A FINAL DESIGN. ALL LOCAL CODES AND REGULATIONS SHALL BE OBTAINED BY THE CONTRACTOR.
 7. 166C TO VERIFY ALL LOCAL CODES AND REGULATIONS.
 8. 166C TO LEAVE 2" SPACES SPRINKLER HEADS IN STORE.


REFLECTED CEILING PLAN
SCALE: 1/8" = 1'-0"

SPRINKLER LEGEND

SYMBOL	DESCRIPTION
○	THIN JET SPRINKLER HEAD (RAULS)
○	5/8" RECESSED SPRINKLER HEAD (RAULS)
○	BROAD FRONT SPRINKLER HEAD (NEWCASTLE)
○	EXISTING SPRINKLER HEADS, PROVIDED AND INSTALLED BY 166C. REFER TO DWG H10 FOR LOCATION.
○	SPRINKLER HEADS, 100% DAYS AND EXISTING TO BE WHITE.

LIGHT FIXTURE SCHEDULE

TYPE	SYMBOL	MANUFACTURER / CATALOGUE NO.	DESCRIPTION	VOLTS	LAMPS	WATTS	REMARKS
A	○	JMO-102-366	RECESSED DOWN LIGHT 3 1/2" RECESSED	120	40W/35W	60W	
B	○	JMO-1136	1/4" VOLTAGE TRACK LIGHT WITH OPEN BACK FRONT LIGHT	120	40W/35W	60W	
C	▽	JMO-1136	1/4" VOLTAGE TRACK LIGHT	120	30W/35W	30W	
D	▽	JMO-1136	RECESSED 1-BAY PENDANT*	-	-	-	
E	▽	JMO-1136	RECESSED 1-BAY PENDANT*	-	-	-	
F	▽	JMO-1136	RECESSED 1-BAY PENDANT*	-	-	-	
G	▽	JMO-1136	RECESSED 1-BAY PENDANT*	-	-	-	
H	▽	JMO-1136	RECESSED 1-BAY PENDANT*	-	-	-	
I	▽	JMO-1136	RECESSED 1-BAY PENDANT*	-	-	-	
J	▽	JMO-1136	RECESSED 1-BAY PENDANT*	-	-	-	
K	▽	JMO-1136	RECESSED 1-BAY PENDANT*	-	-	-	
L	▽	JMO-1136	RECESSED 1-BAY PENDANT*	-	-	-	
M	▽	JMO-1136	RECESSED 1-BAY PENDANT*	-	-	-	
N	▽	JMO-1136	RECESSED 1-BAY PENDANT*	-	-	-	
O	▽	JMO-1136	RECESSED 1-BAY PENDANT*	-	-	-	
P	▽	JMO-1136	RECESSED 1-BAY PENDANT*	-	-	-	
Q	▽	JMO-1136	RECESSED 1-BAY PENDANT*	-	-	-	
R	▽	JMO-1136	RECESSED 1-BAY PENDANT*	-	-	-	
S	▽	JMO-1136	RECESSED 1-BAY PENDANT*	-	-	-	
T	▽	JMO-1136	RECESSED 1-BAY PENDANT*	-	-	-	
U	▽	JMO-1136	RECESSED 1-BAY PENDANT*	-	-	-	
V	▽	JMO-1136	RECESSED 1-BAY PENDANT*	-	-	-	
W	▽	JMO-1136	RECESSED 1-BAY PENDANT*	-	-	-	
X	▽	JMO-1136	RECESSED 1-BAY PENDANT*	-	-	-	
Y	▽	JMO-1136	RECESSED 1-BAY PENDANT*	-	-	-	
Z	▽	JMO-1136	RECESSED 1-BAY PENDANT*	-	-	-	

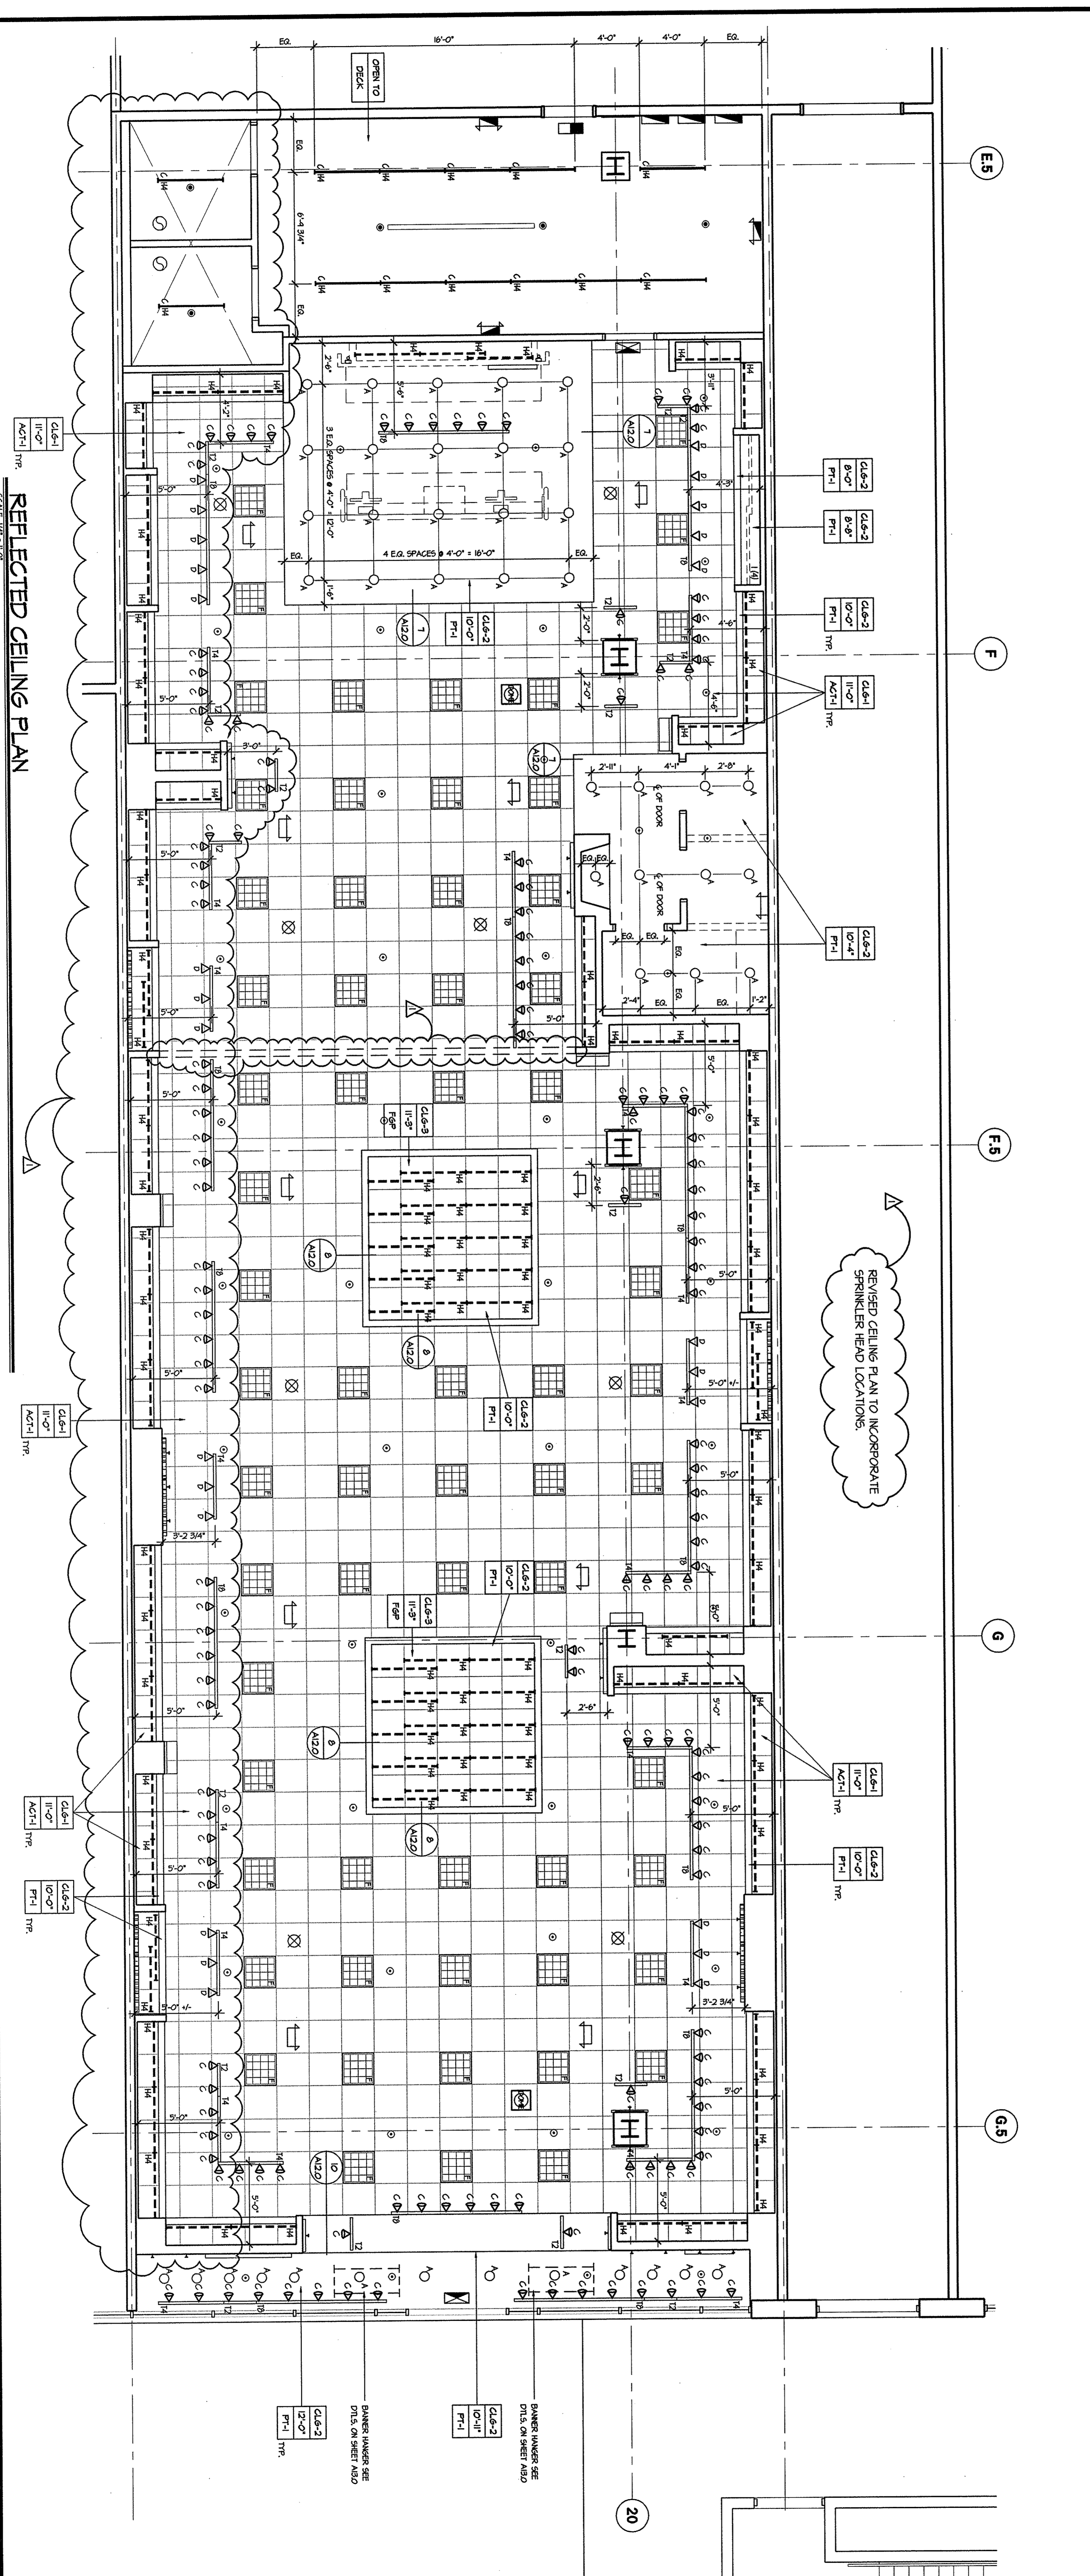

DATE 7-12-01 **ISSUE** CHECK SET
7-19-01 **BID SET**

DATE 8-9-01 **NO.** 1 **REVISION / BY** B.D. COMMENTS
8-31-01 **NO.** 2 **REVISION / BY** B.D. COMMENTS
10-31-01 **NO.** 3 **REVISION / BY** L.L. COMMENTS

ARCHITECT OF RECORD:
NATIVE BUILDING RECENT
1000 W. 10TH AVE.
NORTHWEST, OHIO 43005
PHONE: (614) 436-0000
FAX: (614) 436-0000
CONTACT: JIMMY WALKER

OWNER OF RECORD:
DAVID F. SCHWARTZ
700 PROGRESSIVE BLDG.
WESTERVILLE, OHIO 43081
PHONE: (614) 946-2225
FAX: (614) 946-2531

LOCATION: ORANGE PLAZA REDEVELOPMENT
SPACE #10
MIDDLETOWN, NEW YORK 10940

PROJECT: AVENUE 253

STORE #

DRAWING NAME: REFLECTED CEILING PLAN

PROJECT NO.: AVE240

SCALES: 1/4" = 1'-0"

DATE: 7/19/01

DRAWN BY: STAFF
CHECKED BY: LHC
APPROVED BY: MPM

AREA CALCULATIONS:
SALES AREA: 4361 S.F.
NON-SALES: 550 S.F.
GR253: 5411 S.F.

DRAWING NO.: A2.0

ALL RIGHTS RESERVED