


NOTE: ALL DIMENSIONS AND EXISTING CONDITIONS SHALL BE CHECKED AND VERIFIED BY THE CONTRACTOR IN THE FIELD. SEE DISCLAIMER NOTE ON SHEET 'CS-1'.


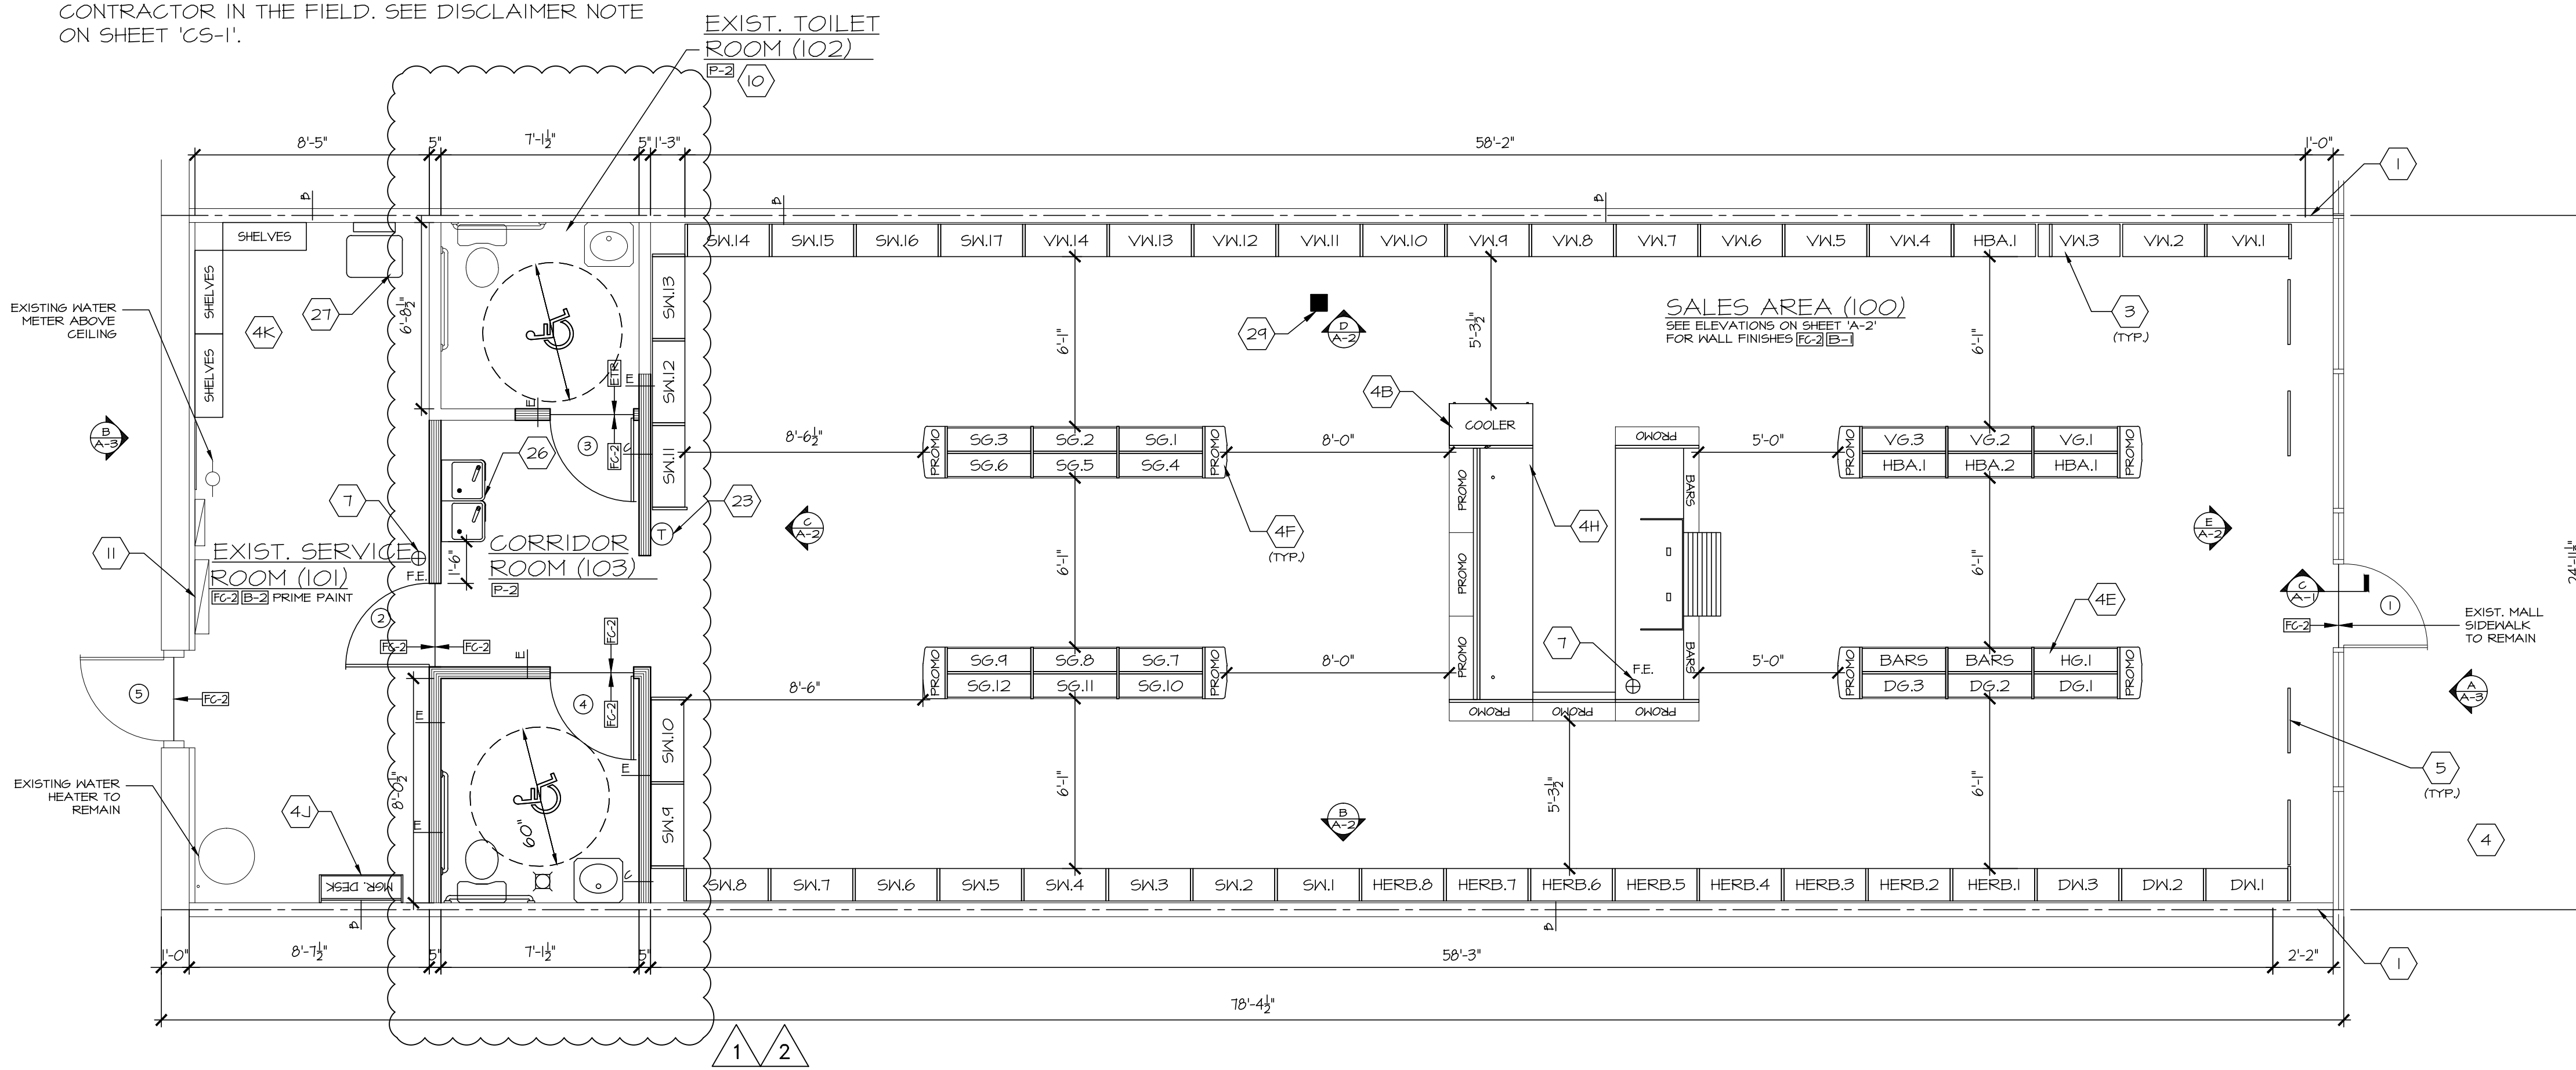


FLOOR PLAN
SCALE: 1/4" = 1'-0"

NOTE: GC TO RELOCATE EXISTING STROBES AND FIRE ALARM PULLS

NOTE: VERIFY EXISTING SPRINKLERHEADS, MECHANICAL GRILLES AND DIFFUSERS TO REMAIN, MODIFY, RELOCATE, OR ADD AS REQUIRED BY NEW CONSTRUCTION AND/OR TO MEET APPLICABLE CODES. COORDINATE WITH DRAWINGS AND TENANT'S CONSTRUCTION DEPARTMENT

NOTE: GC TO COORDINATE W/ TENANT'S CONSTRUCTION DEPARTMENT THE REPOSITIONING OF ANY CEILING ELEMENTS SHOULD ANY CONFLICTS OCCUR BETWEEN THE NEW CEILING LAYOUT AND EXISTING ELEMENTS THAT ARE TO REMAIN.

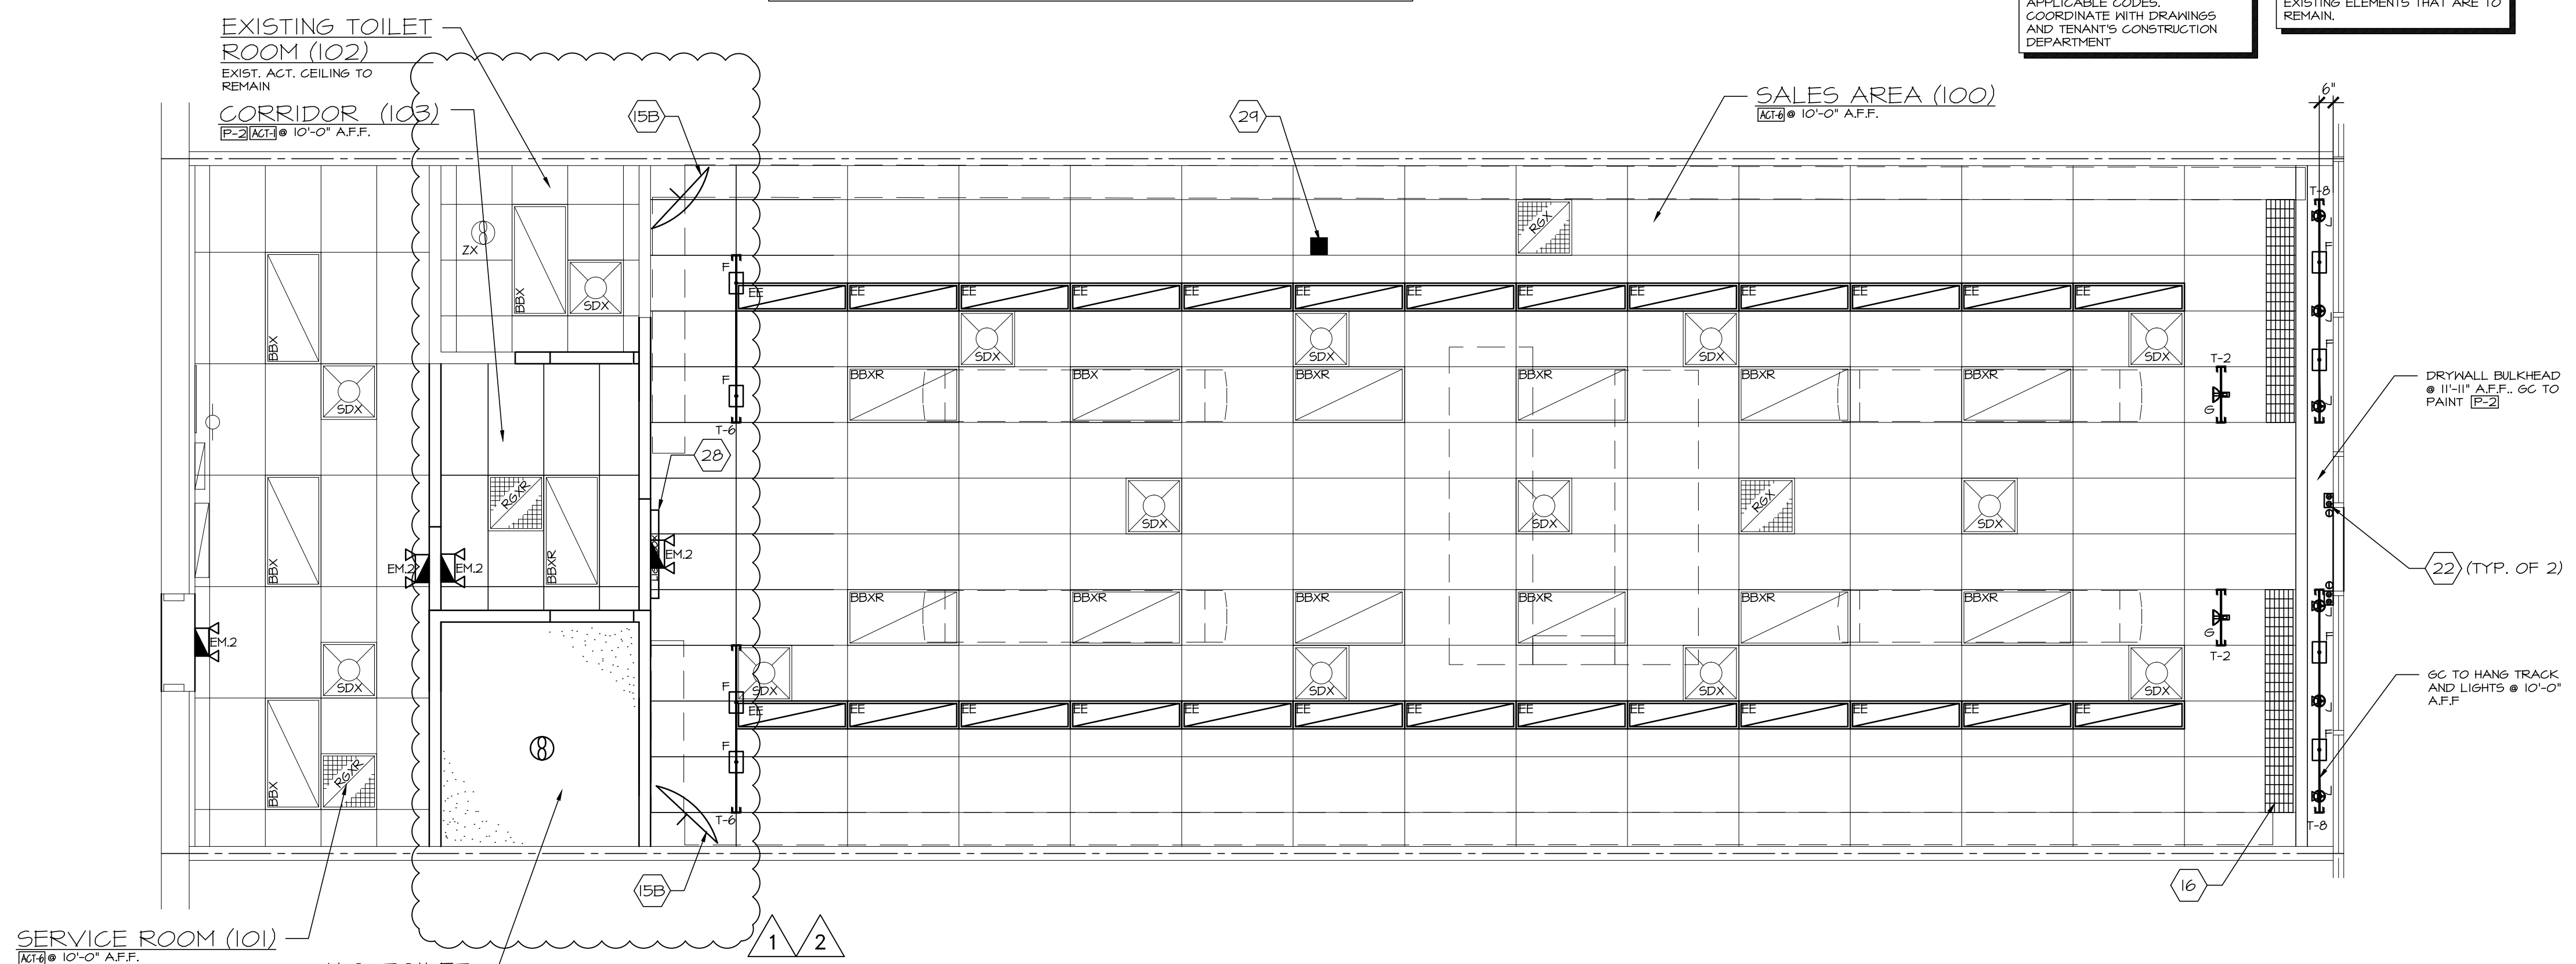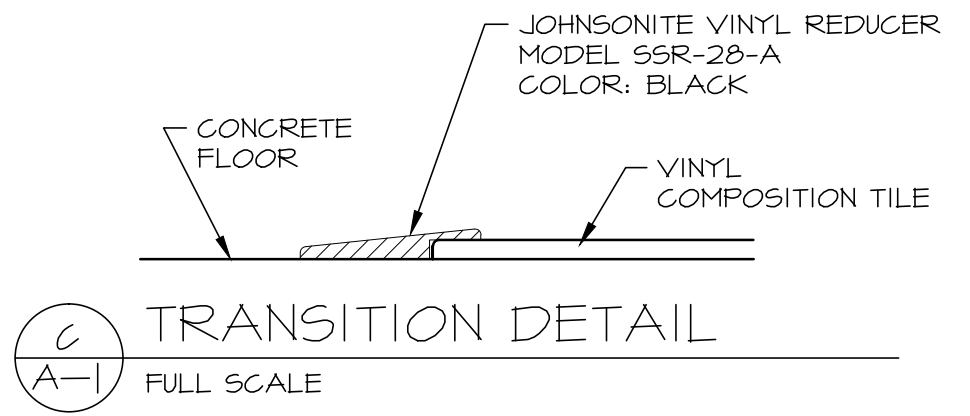

REFLECTED CEILING PLAN
SCALE: 1/4" = 1'-0"

KEY NOTES:

- 1 LEASE LINE
- 3 WALL FIXTURES - SEE DETAIL A/F-2 & B/F-2 (TYPICAL)
- 4 10'-0" x VARIES" x 3/4" WOOD PANEL WITH 8'-0" RECESSED STANDARDS AND (6) 6" DEEP WOOD SHELVES
- 4B SELF-CONTAINED COOLER - SEE ELEC. DWGS
- 4E GONDOLA FIXTURE (TYPICAL)
- 4F GONDOLA ENDCAP (TYPICAL)
- 4H CASH AND WRAP
- 4J MANAGER'S DESK
- 4K SERVICE ROOM SHELVING UNIT (3' LENGTH)
- 5 GRAPHIC DISPLAY SYSTEM - FURNISHED BY TENANT, INSTALLED BY G.C. - SEE DETAIL C/F-1 (TYPICAL)
- 7 10 lb. FIRE EXTINGUISHER - U.L. RATING 4-A-60BC
- 10 EXISTING TOILET ROOM - G.C. SHALL CLEAN AND RENDER EXISTING FIXTURES AND ACCESSORIES TO REMAIN TOTALLY OPERATIONAL TO 'LIKE NEW' CONDITION
- 11 ELECTRICAL EQUIPMENT LOCATION. SEE ELECTRICAL DWGS
- 15B CONVEX SECURITY MIRROR. (TYP. OF 2)
- 16 GRID SYSTEM - G.C. TO NEATLY NOTCH/CUT TO ACCOMMODATE EXISTING SPRINKLER HEAD OR WIDTH OF SHOW WINDOW (TYPICAL)
- 22 G.C. TO FURNISH AND INSTALL 'CEILING' HOOK W/ NON-COMBUSTIBLE BLOCKING FOR SUPPORT LOCATE NEAR DUPLEX ELECTRICAL OUTLET - SEE ELEC. DWGS
- 23 THERMOSTAT (LIGHT-STAT MODEL#TMDABU) FURNISH BY TENANT INSTALLED BY G.C.
- 26 NEW HI-LOW DRINKING FOUNTAIN. PROVIDE FRP MAINSCOT AT ADJACENT WALL SURFACES - FURNISHED AND INSTALLED BY G.C.
- 27 NEW SERVICE SINK. PROVIDE FRP MAINSCOT AT ADJACENT WALL SURFACES - FURNISHED AND INSTALLED BY G.C.
- 28 LIGHT BOX- FURNISHED BY TENANT, INSTALLED BY G.C.
- 29 GC TO PAINT COLUMN [P-2]

FINISH SCHEDULE							
ROOM	FLOOR	WALL	CEILING	COLUMNS	TRIM	DOORS	BASE
SALES AREA (100)	FC-2	NOTE #2	ACT-6	NONE	NOTE #2	NOTE #2	B-1
SERVICE ROOM (101)	FC-2	NOTE #5	ACT-6	NONE	NONE	EXIST.	B-2
TOILET ROOM (102)	ETR	EXIST/[P-2]	EXIST/[P-2]	NONE	NONE	EXIST.	EXIST.

FINISH NOTES:
 1. REFER TO 'CS-2' FOR FLOOR COVERING, PAINT, STAIN AND BASE MATERIALS.
 2. SEE ELEVATIONS ON SHEET 'A-2' FOR FINISHES AND GRAPHICS LOCATIONS AND CLARIFICATIONS.
 3. G.C. TO PAINT FRAME ONLY [P-2]
 4. INSTALL BASE TO MATCH EXISTING AT NEW PARTITIONS
 5. PRIME PAINT NEW PARTITIONS ONLY

MERCHANDISE FIXTURE TYPES			
VN	VITAMIN WALL FIXTURE	VG	VITAMIN GONDOLA FIXTURE
DN	DIET WALL FIXTURE	SG	SPORTS GONDOLA FIXTURE
ENERGY	ENERGY WALL FIXTURE	PC	PERSONAL CARE GONDOLA FIXTURE
HERB	HERB WALL FIXTURE	NRG	NATURAL REMEDIES GONDOLA FIXTURE
NRM	NATURAL REMEDIES WALL FIXTURE	R.T.D.	READY TO DRINK GONDOLA FIXTURE
SN	SPORTS WALL FIXTURE	BARS	BARS GONDOLA FIXTURE
SNACKS	SNACKS GONDOLA FIXTURE	FOOD	FOOD GONDOLA FIXTURE

CEILING LEGEND	
	2' x 4' RECESSED FLUORESCENT W/ PRISMATIC LENSE
	2' x 4' RECESSED FLUORESCENT W/ PRISMATIC LENSE - NIGHT LIGHT
	1' x 4' RECESSED WALLWASHER
	1' x 2' RECESSED WALLWASHER
	INCANDESCENT TRACK HEAD
	SURFACE MTD. TRACK
	48" TWO LAMP OPEN STRIP LIGHT
	BIAX TRACK HEAD
	WALLWASHER TRACK HEAD
	DOWNLIGHT
	ADJUSTABLE DOWNLIGHT
	TRACK MOUNTED SPOT
	L.E.D. EXIT SIGN W/ DUAL EMERGENCY LIGHTS
	FLUSH MOUNTED SPRINKLER HEAD
	SEMI-RECESSED SPRINKLER HEAD
	FULLY-RECESSED SPRINKLER HEAD
	FAN/LIGHT COMBO
	RETURN AIR GRILLE
	SUPPLY AIR DIFFUSER

GNC LiveWell.
 GENERAL NUTRITION CENTER, INC.
 300 SIXTH AVENUE, PITTSBURGH, PA 15222
 PHONE: 412-338-8967 FAX: 412-338-8878

RSW CONSULTANTS
 17211 EAGLE HOLLOW
 SAN ANTONIO, TX 78248
 PHONE: 210-408-1860

NO.	DATE	DESCRIPTION	BY	APPR.
2	2/10/10	REVISIONS PER BLDG DEPT SKM		
1	2/23/10	INTERNAL REVISIONS SKM		

GNC
 NORTH HAVEN PAVILLION
 200 UNIVERSAL DRIVE
 NORTH HAVEN, CT 06473
 SPACE # 110

Store No. 2254
 Drawn by: MWS Date: 1/13/2010
 Checked By: RR Date: DATE CHECKED
 Drawing Name: 02254.DWG
 Drawing No. A-1